


CORP "C"

CORP "B"

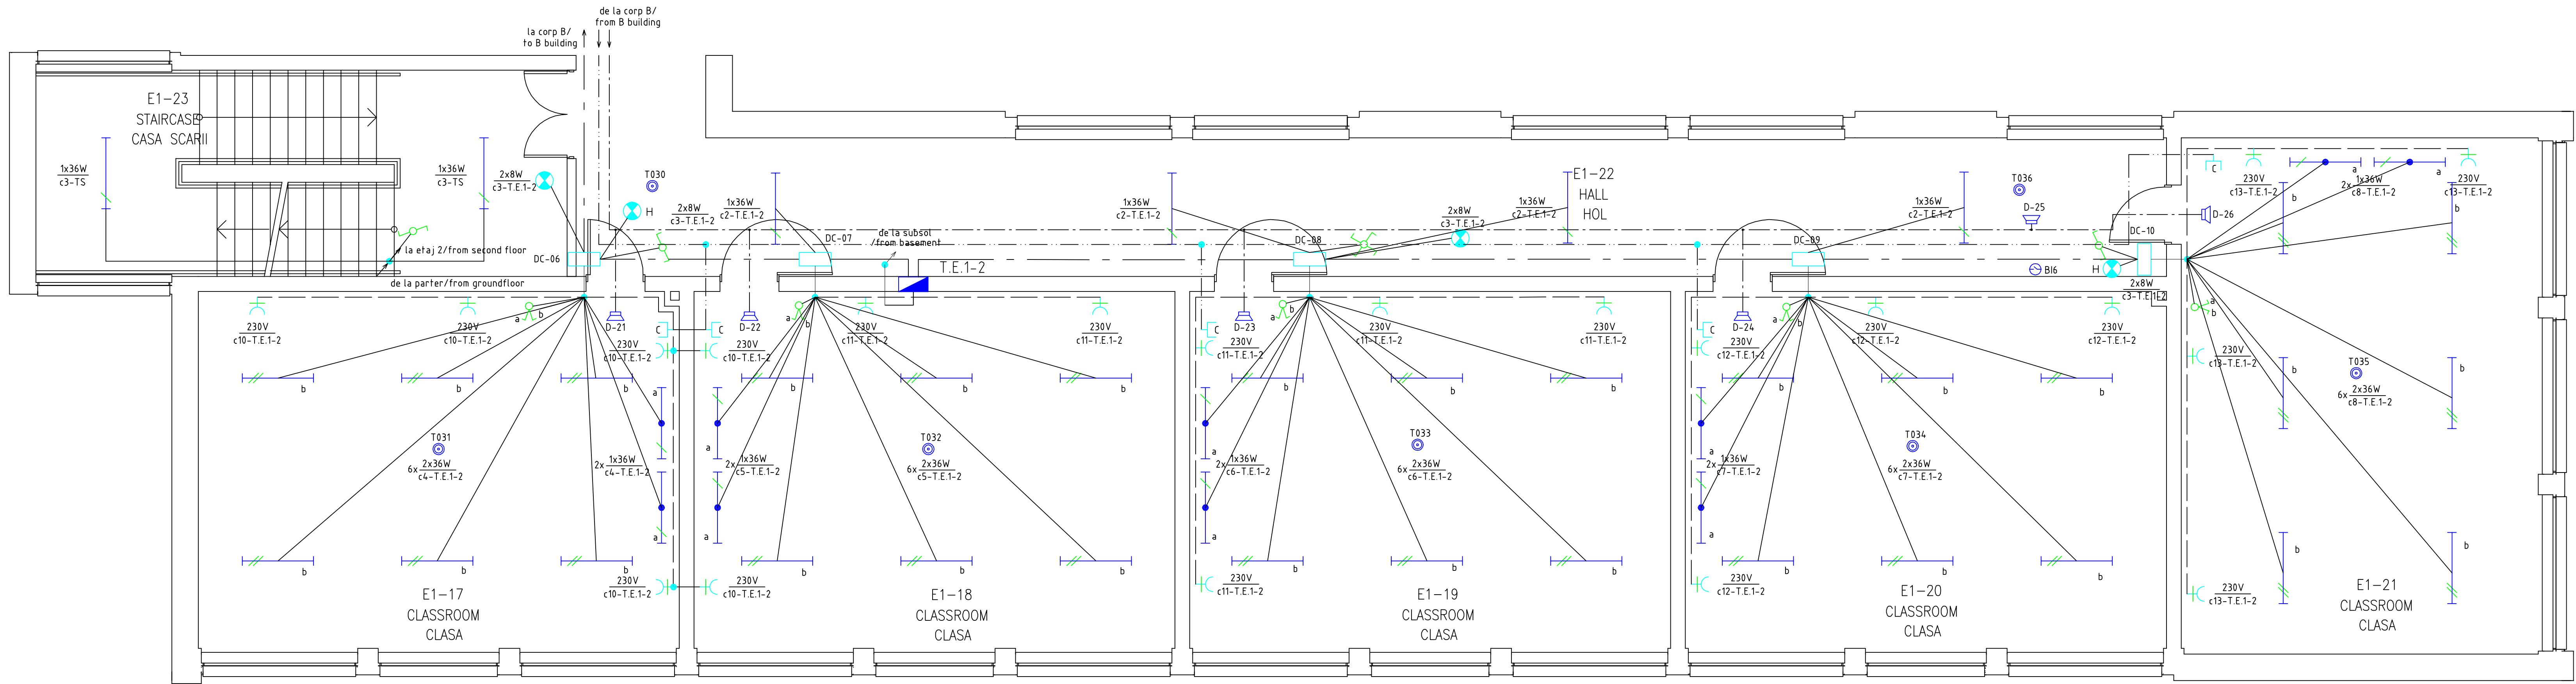

LEGENDA:

- ⊗ — Corp de iluminat tip aplica 1x60W
Lighting fixture bracket type 1x60W
- — Corp de iluminat fluorescent 2x36W montat aparent
Fluorescent lighting fixture 2x36W apparent munting
- — Corp de iluminat fluorescent 1x36W montat aparent
Fluorescent lighting fixture 1x36W apparent munting
- — Corp de iluminat fluorescent 2x18W montat aparent, constructie etansa
Fluorescent lighting fixture 2x18W apparent munting, water proof construction
- — Corp de iluminat fluorescent 1x18W montat aparent, constructie etansa
Fluorescent lighting fixture 1x18W apparent munting, water proof construction
- — Corp de iluminat fluorescent 1x36W montat aparent, constructie etansa
Fluorescent lighting fixture 1x36W apparent munting, water proof construction
- — Corp de iluminat fluorescent 2x8W montat aparent pentru evacuare
Fluorescent lighting fixture 2x8W apparent munting to evacuate
- — Corp de iluminat fluorescent 2x8W montat aparent pentru hidranti
Fluorescent lighting fixture 2x8W apparent munting for hydrants
- — Intrerupator simplu 250V/10A
One way switch 250V/10A
- — Intrerupator dublu 250V/10A
One way two poles switch 250V/10A
- — Intrerupator cap scara 250V/10A
One way stair switch 250V/10A
- — Intrerupator cruce 250V/10A
One way cross switch 250V/10A
- — Priza 16A/230V cu contact de protectie
Socket 16A/230V with earth contact
- — Priza 16A/230V cu contact de protectie, constructie etansa
Socket 16A/230V with earth contact water proof construction
- — Priza telefon
Phone socket
- — Priza calculator
Calculator socket
- — Priza calculator
Calculator socket
- — Traseu circuite montat in tub de protectie
Circuit copre mounted in protection tube
- — Traseu circuite multiple
Multiple circuit
- — Traseu calculator
Calculator copre
- — Traseu difuzoare
Speakers copre
- — Apelator telefonic/Phone
Centrala avertizare incendiu/Fire station
- — Buton incendiu/Fire button
Detector optic de fum/Optic smoke detector
- — Sirena incendiu/Fire siren
- — Difuzor / Speaker
- — Amplificator

NOTA: ALL MEASUREMENTS SHOULD BE MADE ON SITE/TOATE MASURATORILOR SA SE FACA LA FATA LOCULUI

VERIFICATOR: M.L.P.A.T.	NUME: NAME	SERINATURA: SIGNATURE	CERINTA: REQUIREMENT	REFERAT / EXPERTIZA NR.: DATA REPORT / TECHNICAL EXPERTISE / DATE
VERIFICATOR: M.L.P.A.T.	NUME: NAME	SERINATURA: SIGNATURE	CERINTA: REQUIREMENT	REFERAT / EXPERTIZA NR.: DATA REPORT / TECHNICAL EXPERTISE / DATE
PROJECT DESIGN COORDINATOR: COORDINATOR PROJECT: THE LOUIS BERGER GROUP, INC.				
BUCHAREST SCHOOLS INFRASTRUCTURE REHABILITATION / REABILITAREA INFRASTRUCTURII EDUCATIONALE IN MUNICIPIUL BUCURESTI				
DESIGNER/PROJECTANT:	M4	M3	M2	M1
DESIGNED BY PROJECT:	DESIGNED BY/PROJECTANT	VERIFIED BY/VERIFY	PROJ. DIR./SET PROJECT	
VERIFIED BY PROJECT:	VERIFIED BY/VERIFY	PROJ. DIR./SET PROJECT		
PROJ. DIR. SET PROJECT	PROJ. DIR. SET PROJECT	PROJ. DIR. SET PROJECT		
BENEFICIARY/BENEFICIAR: MUNICIPALITY OF BUCHAREST PRIMARIA MUNICIPIULUI BUCURESTI				
SCHOOL NAME/ NOME SCOLA: General School no. 36 / Scoala Generala nr. 36				
ELECTRICAL INSTALATION / INSTALATI ELECTRICE BUILDING "C" / CORP "C"				
1 ST FLOOR PLAN PLAN ETAJ 1				
DATE/ DATA: 04/2006				
SCALE/ SCALA: 1 : 50				
DEMPLAR NR.: 06/54				
PROJ. PHASE/FAZA PROJECT: Detailed Design				
PROJ. NO./NO PROJECT: 06/54				
DRWG. NO./NO. PLANSA: A - EL - 011				