


CORP "B"

CORP "A"

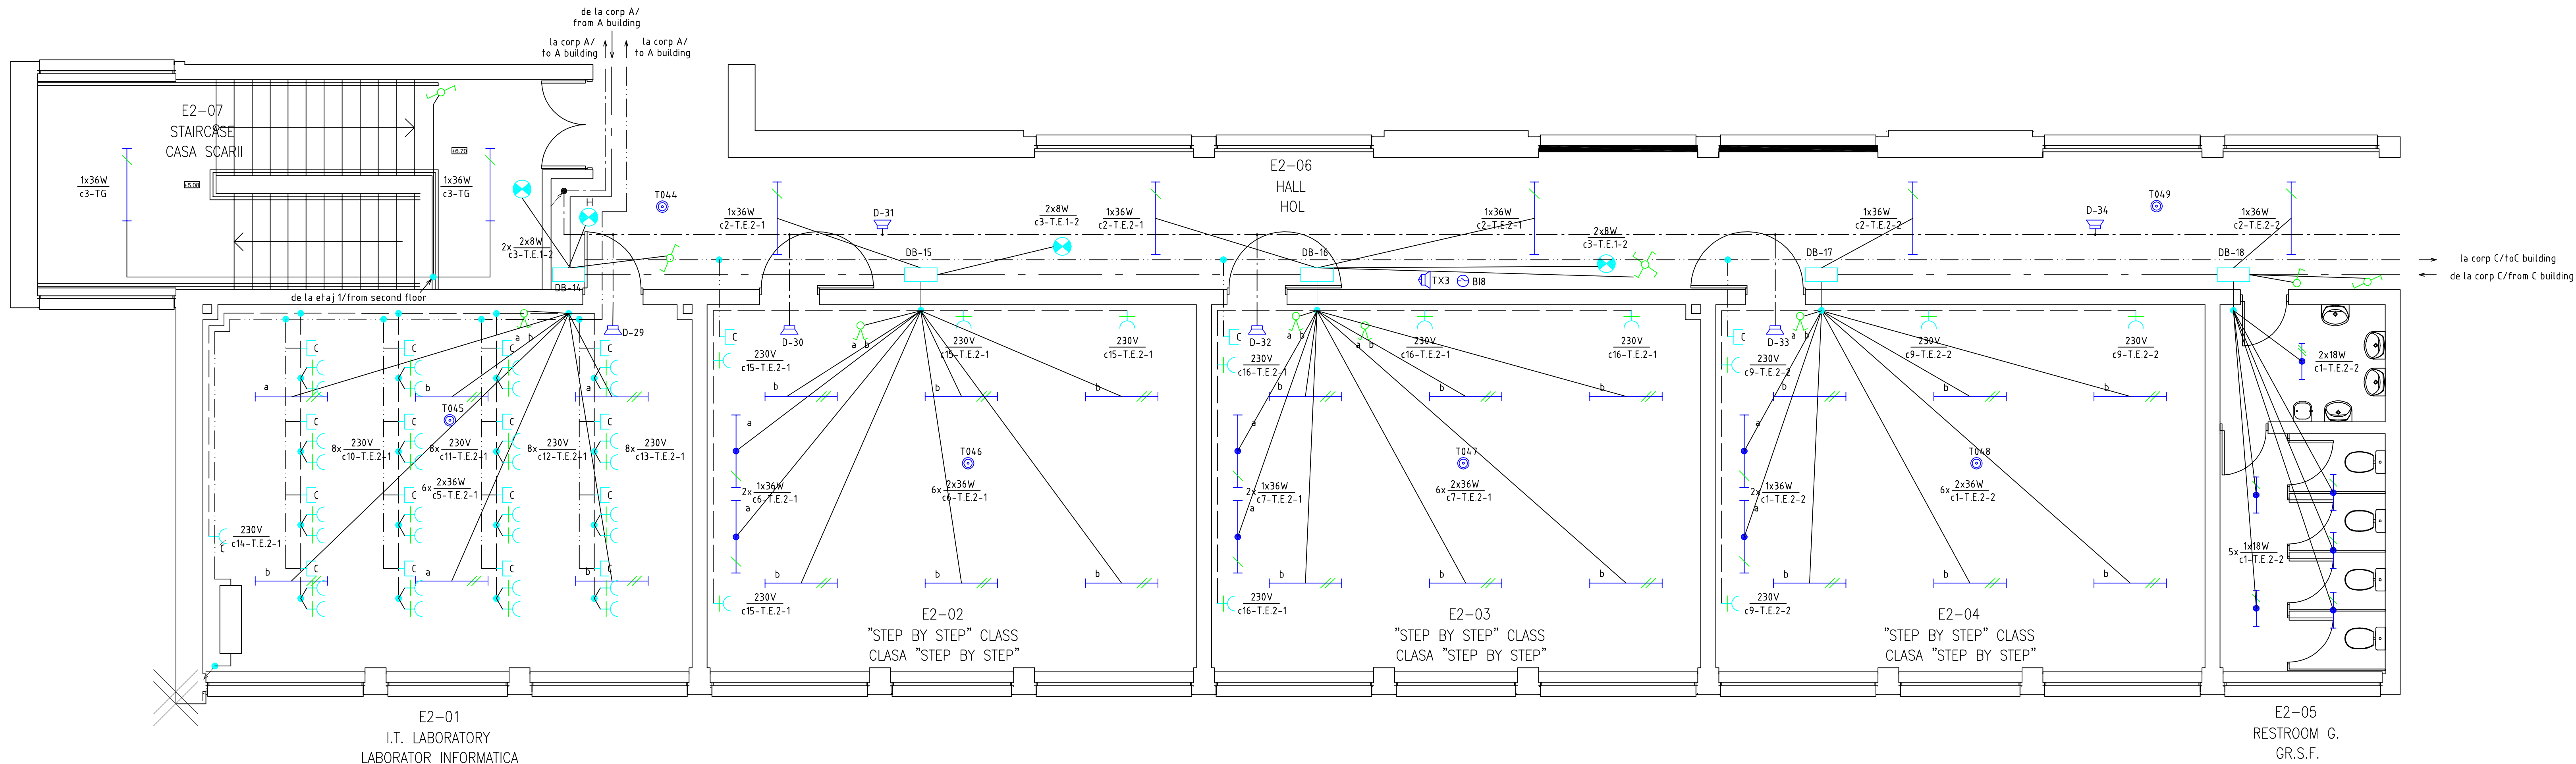

LEGENDA:

- ⊗ Corp de iluminat tip aplica 1x60W  
Lighting fixture bracket type 1x60W
- / — Corp de iluminat fluorescent 2x36W montat aparent  
Fluorescent lighting fixture 2x36W apparent mounting
- / — Corp de iluminat fluorescent 1x36W montat aparent  
Fluorescent lighting fixture 1x36W apparent mounting
- / — Corp de iluminat fluorescent 2x18W montat aparent, construcție etansă  
Fluorescent lighting fixture 2x18W apparent mounting, water proof construction
- / — Corp de iluminat fluorescent 1x18W montat aparent, construcție etansă  
Fluorescent lighting fixture 1x18W apparent mounting, water proof construction
- / — Corp de iluminat fluorescent 1x36W montat aparent, construcție etansă  
Fluorescent lighting fixture 1x36W apparent mounting, water proof construction
- ⊗ Corp de iluminat fluorescent 2x8W montat aparent pentru evacuare  
Fluorescent lighting fixture 2x8W apparent mounting to evacuate
- ⊗ Corp de iluminat fluorescent 2x8W montat aparent pentru hidranți  
Fluorescent lighting fixture 2x8W apparent mounting for hydrants
- / — Intrerupator simplu 250V/10A  
One way switch 250V/10A
- / — Intrerupator dublu 250V/10A  
One way two poles switch 250V/10A
- / — Intrerupator cap scara 250V/10A  
One way stair switch 250V/10A
- / — Intrerupator cruce 250V/10A  
One way cross switch 250V/10A
- / — Priza 16A/230V cu contact de protecție  
Socket 16A/230V with earth contact
- / — Priza 16A/230V cu contact de protecție, construcție etansă  
Socket 16A/230V with earth contact water proof construction
- / — Priza telefon  
Phone socket
- / — Priza calculator  
Calculator socket
- / — Priza calculator  
Calculator socket
- / — Traseu circuite montat in tub de protecție  
Circuit copre mounted in protection tube
- / — Traseu circuite multiple  
Multiple circuit
- / — Traseu calculator  
Calculator copre
- / — Traseu difuzoare  
Speakers copre
- / — Apelator telefonic/Phone
- / — Centrala avertizare incendiu/Fire station
- / — Buton incendiu/Fire button
- / — Detector optic de fum/Optic smoke detector
- / — Sirena incendiu/Fire siren
- / — Difuzor / Speaker
- / — Amplificator

NOTA: ALL MEASUREMENTS SHOULD BE MADE ON SITE/TOATE MASURATORILOR SA SE FAÇA LA FATA LOCULUI

VERIFICATOR VERIFICATOR P.A.T.	NUME NAME	SIGNATURA SIGNATURE	CERINTA REQUIREMENT	REFERAT / EXPERTIZA NR. / DATA REPORT / TECHNICAL EXPERTISE / DATE
PROJECT DESIGN COORDINATOR: COORDINATOR PROJECT:				
BUCHAREST SCHOOLS INFRASTRUCTURE REHABILITATION / REABILITAREA INFRASTRUCTURII EDUCATIONALE IN MUNICIPIUL BUCURESTI				
DESIGNER/PROJECTANT:				
BENEFICIARY/BENEFICIAR: MUNICIPALITY OF BUCHAREST PRIMARIA MUNICIPIULUI BUCURESTI				
SCHOOL NAME/ NOME SCOLA				
General School no. 38 / Scoala Generala nr. 38				
ELECTRICAL INSTALLATION / INSTALATII ELECTRICE				
BUILDING "B" / CORP "B"				
2 ND FLOOR PLAN				
PLAN ETAJ 2				
DATE / DATA				
04/2006				
1 : 50				
EXEMPLAR NR.				
PROJ. PHASE/FAZA PROJECT				
Detailed Design				
PROJ. No./Nr. PROJECT				
063/84				
DWG. No./Nr. PLANS				
A - EL - 008				