


CORP "C"

CORP "B"

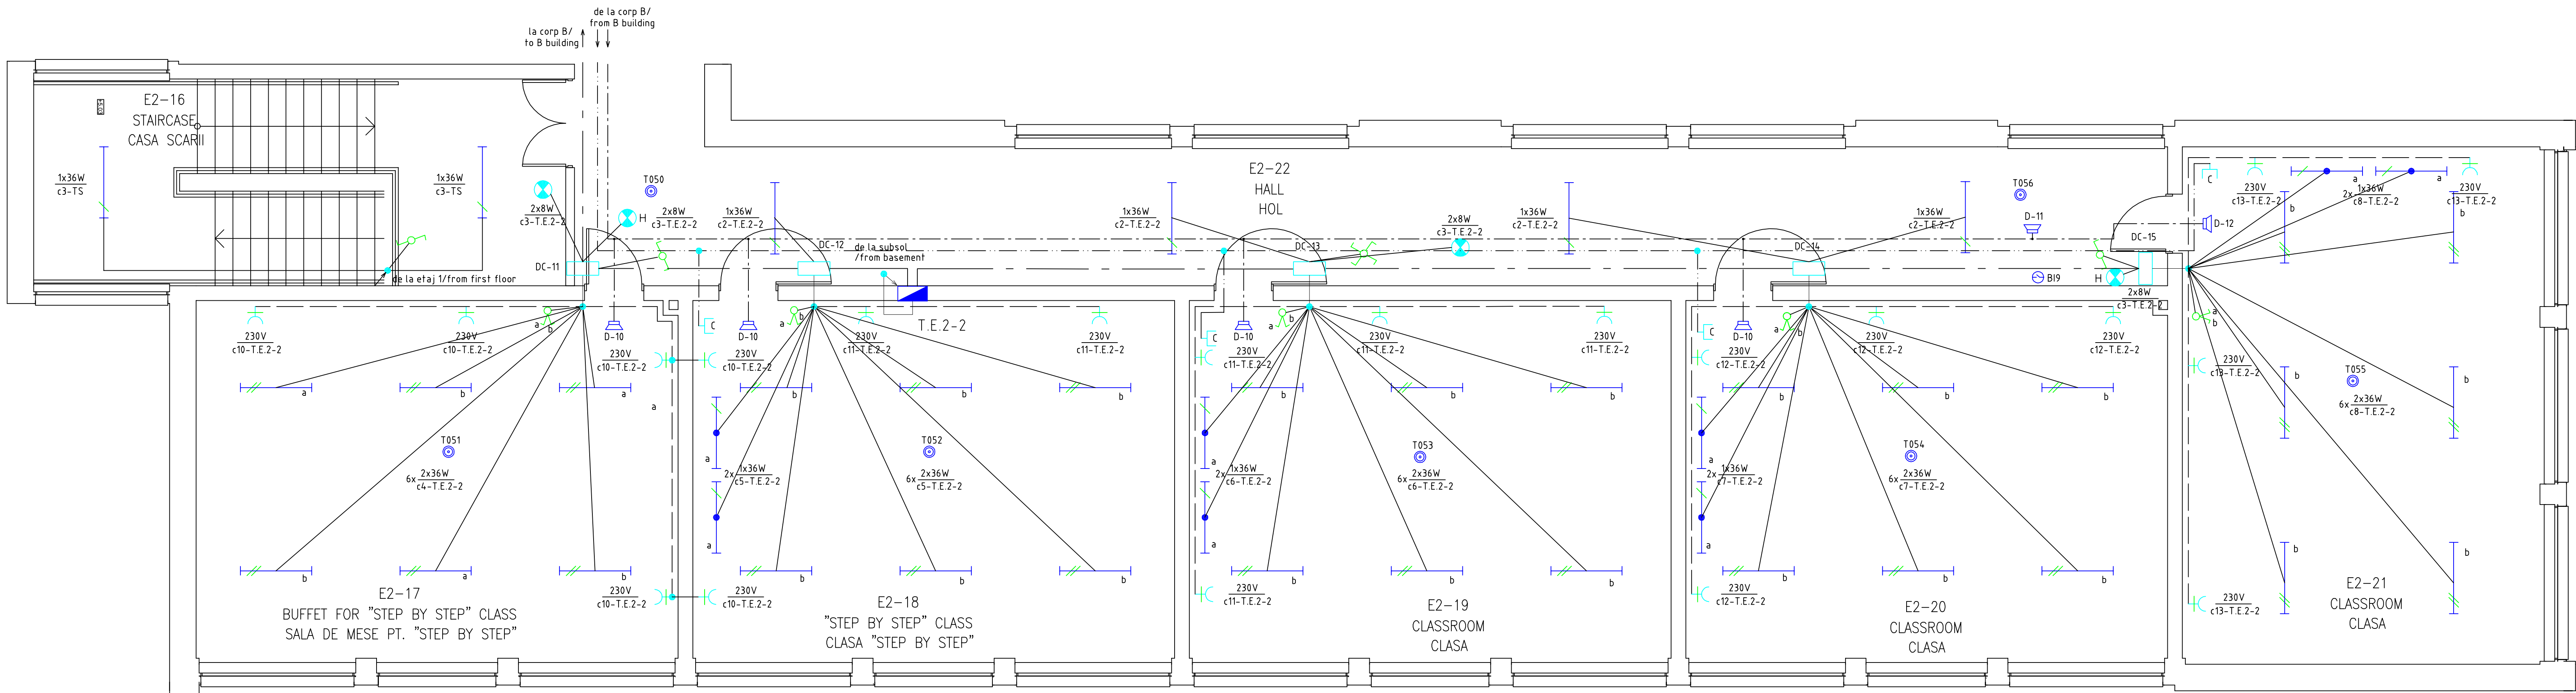

LEGENDA:

- Corp de iluminat tip aplica 1x60W
Lighting fixture bracket type 1x60W
- Corp de iluminat fluorescent 2x36W montat aparent
Fluorescent lighting fixture 2x36W apparent mounting
- Corp de iluminat fluorescent 1x36W montat aparent
Fluorescent lighting fixture 1x36W apparent mounting
- Corp de iluminat fluorescent 2x18W montat aparent, constructie etansa
Fluorescent lighting fixture 2x18W apparent mounting, water proof construction
- Corp de iluminat fluorescent 1x18W montat aparent, constructie etansa
Fluorescent lighting fixture 1x18W apparent mounting, water proof construction
- Corp de iluminat fluorescent 1x36W montat aparent, constructie etansa
Fluorescent lighting fixture 1x36W apparent mounting, water proof construction
- Corp de iluminat fluorescent 2x8W montat aparent pentru evacuare
Fluorescent lighting fixture 2x8W apparent mounting to evacuate
- Corp de iluminat fluorescent 2x8W montat aparent pentru hidranti
Fluorescent lighting fixture 2x8W apparent mounting for hydrants
- Interrupator simplu 250V/10A
One way switch 250V/10A
- Interrupator dublu 250V/10A
One way two poles switch 250V/10A
- Interrupator cap scara 250V/10A
One way stair switch 250V/10A
- Interrupator cruce 250V/10A
One way cross switch 250V/10A
- Priza 16A/230V cu contact de protectie
Socket 16A/230V with earth contact
- Priza 16A/230V cu contact de protectie, constructie etansa
Socket 16A/230V with earth contact water proof construction
- Priza telefon
Phone socket
- Priza calculator
Calculator socket
- Traseu circuite montat in tub de protectie
Circuit copre mounted in protection tube
- Traseu circuite multiple
Multiple circuit
- Traseu calculator
Calculator copre
- Traseu difuzoare
Speakers copre
- Apelator telefonic/Phone
Centrala avertizare incendiu/Fire station
- Buton incendiu/Fire button
- Detector optic de fum/Optic smoke detector
- Sirena incendiu/Fire siren
- Difuzor / Speaker
- Amplificator

NOTA: ALL MEASUREMENTS SHOULD BE MADE ON SITE/TOATE MASURATORILOR SA SE FACA LA FATA LOCUILUI

VERIFICATOR: M.L.P.A.T.	NUME: NAME	SERINATURA: SIGNATURE	CERTIFICAT: REQUIREMENT	REFERAT / EXPERTIZA NR. / DATA: REPORT / TECHNICAL EXPERTISE / DATE
VERIFICATOR: M.L.P.A.T.	NUME: NAME	SERINATURA: SIGNATURE	CERTIFICAT: REQUIREMENT	REFERAT / EXPERTIZA NR. / DATA: REPORT / TECHNICAL EXPERTISE / DATE
PROJECT DESIGN COORDINATOR: COORDINATOR PROJECT: THE LOUIS BERGER GROUP, INC.				
BUCHAREST SCHOOLS INFRASTRUCTURE REHABILITATION / REABILITAREA INFRASTRUCTURII EDUCATIONALE IN MUNICIPIUL BUCURESTI				
DESIGNER/PROJECTANT: CONSILIER CONSTRUCT				
BENEFICIARY/CLIENT: MUNICIPALITY OF BUCHAREST PRIMARIA MUNICIPIULUI BUCURESTI				
SCHOOL NAME/ Numele Scolii: General School no. 36 / Scoala Generala nr. 36				
ELECTRICAL INSTALLATION / INSTALATII ELECTRICE				
BUILDING "C" / CORP "C"				
2 ND FLOOR PLAN PLAN ETAJ 2				
DATE/ DATA: 04/2008				
SCALE/ SCALA: 1 : 50				
EXEMPLAR NR. 063/54				
PROJ. PHASE/FAZA PROJECT: Design/Design				
PROJ. NO./Nr. PROJECT: 063/54				
DRWG. No./Nr. PLANA: A - EL - 012				