



CORP "C"

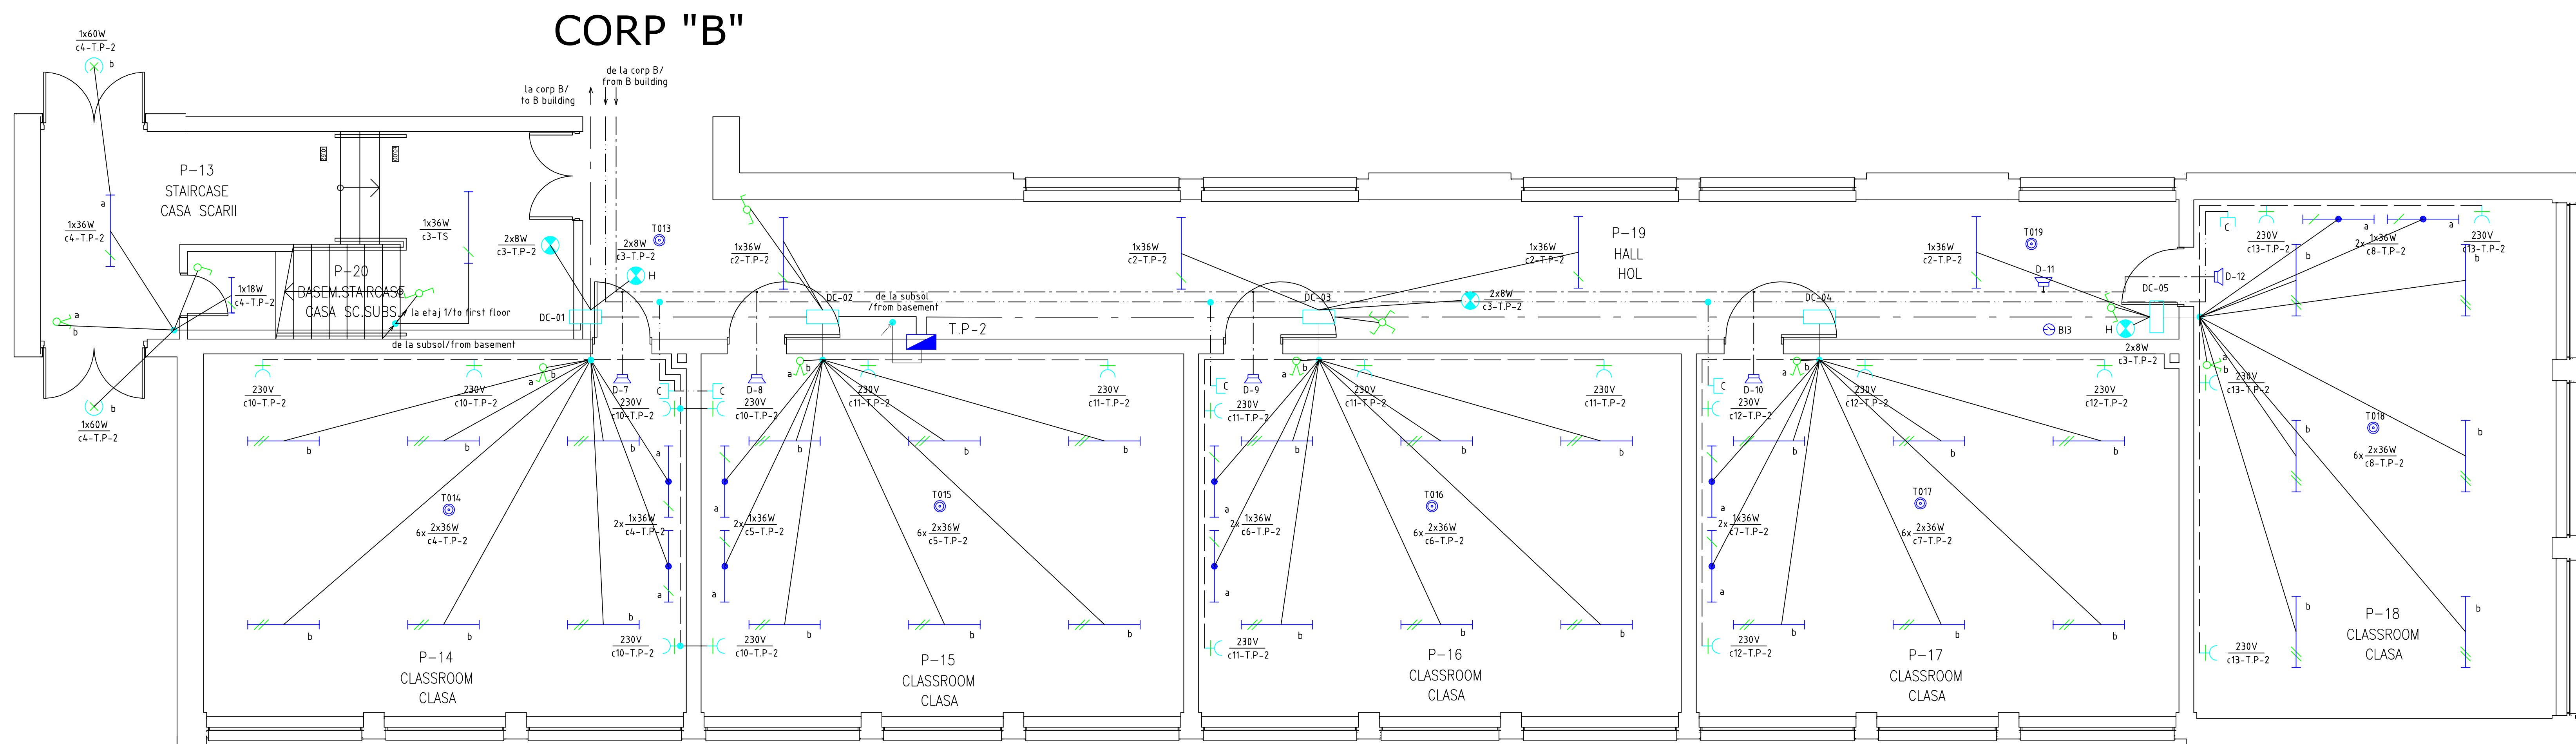

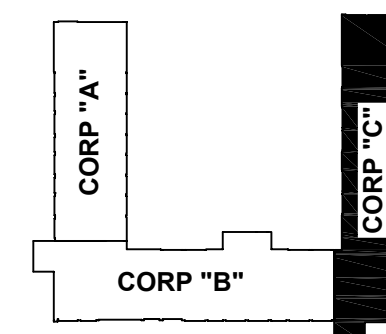


LEGENDA:

- |  |  |
|--|--|
|  | — Corp de iluminat tip aplicarea 1x60W   |
|  | — Lighting fixture bracket type 1x60W  |
|  | — Corp de iluminat fluorescent 2x36W montat aparent                              |
|  | — Fluorescent lighting fixture 2x36W apparent mounting                           |
|  | — Corp de iluminat fluorescent 1x36W montat aparent                              |
|  | — Fluorescent lighting fixture 1x36W apparent mounting                           |
|  | — Corp de iluminat fluorescent 2x18W montat aparent, constructie etansa          |
|  | — Fluorescent lighting fixture 2x18W apparent mounting, water proof construction |
|  | — Corp de iluminat fluorescent 1x18W montat aparent, constructie etansa          |
|  | — Fluorescent lighting fixture 1x18W apparent mounting, water proof construction |
|  | — Corp de iluminat fluorescent 1x36W montat aparent, constructie etansa          |
|  | — Fluorescent lighting fixture 1x36W apparent mounting, water proof construction |
|  | — Corp de iluminat fluorescent 2x8W montat aparent pentru evacuare               |
|  | — Fluorescent lighting fixture 2x8W apparent mounting for evacuation             |
|  | — Corp de iluminat fluorescent 2x8W montat aparent pentru hidranti               |
|  | — Fluorescent lighting fixture 2x8W apparent mounting for hydrants               |
|  | — Interupator simplu 250V/10A  |
|  | — One way switch 250V/10A  |
|  | — Interupator dublu 250V/10A   |
|  | — One way two poles switch 250V/10A  |
|  | — Interupator cap scara 250V/10A   |
|  | — One way stair switch 250V/10A  |
|  | — Interupator cruce 250V/10A   |
|  | — One way cross switch 250V/10A  |
|  | — Priza 16A/230V cu contact de protectie   |
|  | — Socket 16A/230V with earth contact   |
|  | — Priza 16A/230V cu contact de protectie, constructie etansa                     |
|  | — Socket 16A/230V with earth contact water proof construction                    |
|  | — Priza telefon  |
|  | — Phone socket   |
|  | — Priza calculator   |
|  | — Calculator socket  |
|  | — Priza calculator   |
|  | — Calculator socket  |
|  | — Traseu circuite montat in tub de protectie                                     |
|  | — Circuit copre mounted in protection tube                                       |
|  | — Traseu circuite multiple   |
|  | — Multiple circuit   |
|  | — Traseu calculator  |
|  | — Calculator copre   |
|  | — Traseu difuzoare   |
|  | — Speakers copre   |
|  | — AT   |
|  | — Apelator telefonic/Phone   |
|  | — Centrala avertizare incendiu/Fire station                                      |
|  | — Buton incendiu/Fire button   |
|  | — Detector optic de fum/Optic smoke detector                                     |
|  | — Sirena incendiu/Fire siren   |
|  | — Difuzor / Speaker  |
|  | — Amplificator   |



NOTA: ALL MEASUREMENTS SHOULD BE MADE ON SITE/TOATE MASURATORILOR SA SE FACA LA FATA LOCULUI

VERIFICATOR VERIFICATOR	M.P.T. M.P.T.	NOME NOME	SEMINATURA SEMINATURA	CERTATA REQUIREMENT	REFERAT / EXPERTIZA NR. / DATA REPORT / TECHNICAL EXPERTISE / DATE
PROJECT DESIGN COORDINATOR COORDINATOR (PROJECT):				<b>THE LOUIS BERGER GROUP, INC</b>	
<b>BUCHAREST SCHOOLS INFRASTRUCTURE RENHAVILATION / REABILITAREA INFRASTRUCTURII EDUCATIONALE IN MUNICIPIUL BUCURESTI</b>					
DESIGNER (PROJECT):					
		S1A			
		S13			
		S12			
		S11			
Modif		Date/Data	DESIGNED BY/PROJECTAT	VERIFIED BY / VERIFICAT	PROJ. DIR./SEF PROJECT
IDENTIFY/RENTION: MUNICIPALITY OF BUCHAREST PRIMARIA MUNICIPIULUI BUCURESTI			SCHOOL NAME/ NOME ȘCOLII	General School no. 36 / Școala Generală nr. 36	
DESIGNED BY PROJECTAT		NAME / NOME	SIGNAT / SEMNATURA	ELECTRICAL INSTALLATION / INSTALATAI ELECTRICE	
VERIFIED BY VERIFICAT	Ing. V. MATEI			BUILDING "C" / CORP "C"	
PROJ. DIR. SEF PROJECT	Ing. M. HONORESCU			GROUND FLOOR PLAN PLAN PARTER	
DATE / DATA	SCALE / SCARA	EXEMPLAR NR.		PROJ. PHASE / FAZA PROJECT Detailed Design Proiect tehnic	PROJ. NO./Nr. PLANSA 0635/84
04/2006	1 : 50			DWG. NO./Nr. PLANSA A - EL - 010	